


FOR 100 SQ.MT. = 33.30 PERSONS FOR 100 SQ.MT. = 16.60 PERSONS
207.76 SQ.MT. = 66.6 PERSONS 207.76 SQ.MT. = 33.20 PERSONS
TOTAL PERSONS = 100.00


	GENTES (1/2) = 50.00 NO.S	LADIES (1/2) =50.00 NO.S
W.C.	REQ. 25 NOS = 1 NO. 50 NOS = 2 NO	REQ. 15 NOS = 1 NO. 50 NOS = 3 NO
URINAL	REQ. 25 NOS = 1 NO. 50 NOS = 2 NO	
WASH BASIN	REQ. 25 NOS = 1 NO. 50 NOS = 2 NO	REQ. 25 NOS = 1 NO. 50 NOS = 2 NO

BUILT UP AREA CALCULATION									
SANITARY REQUIREMENT ADMINISTRATION BLOCK GROUND FLOOR									
1		16.13	X	11.03	X	1 NO	=	177.91	SQ.MT.
2		5.74	X	5.20	X	1 NO	=	29.85	SQ.MT.
TOTAL ADDITION							=	207.76	SQ.MT. X

BUILT UP AREA CALCULATION						
TOILET						
1	3.51	X	7.28	X	1 NO	= 25.55 SQ.MT.
TOTAL ADDITION					=	25.55 SQ.MT. X

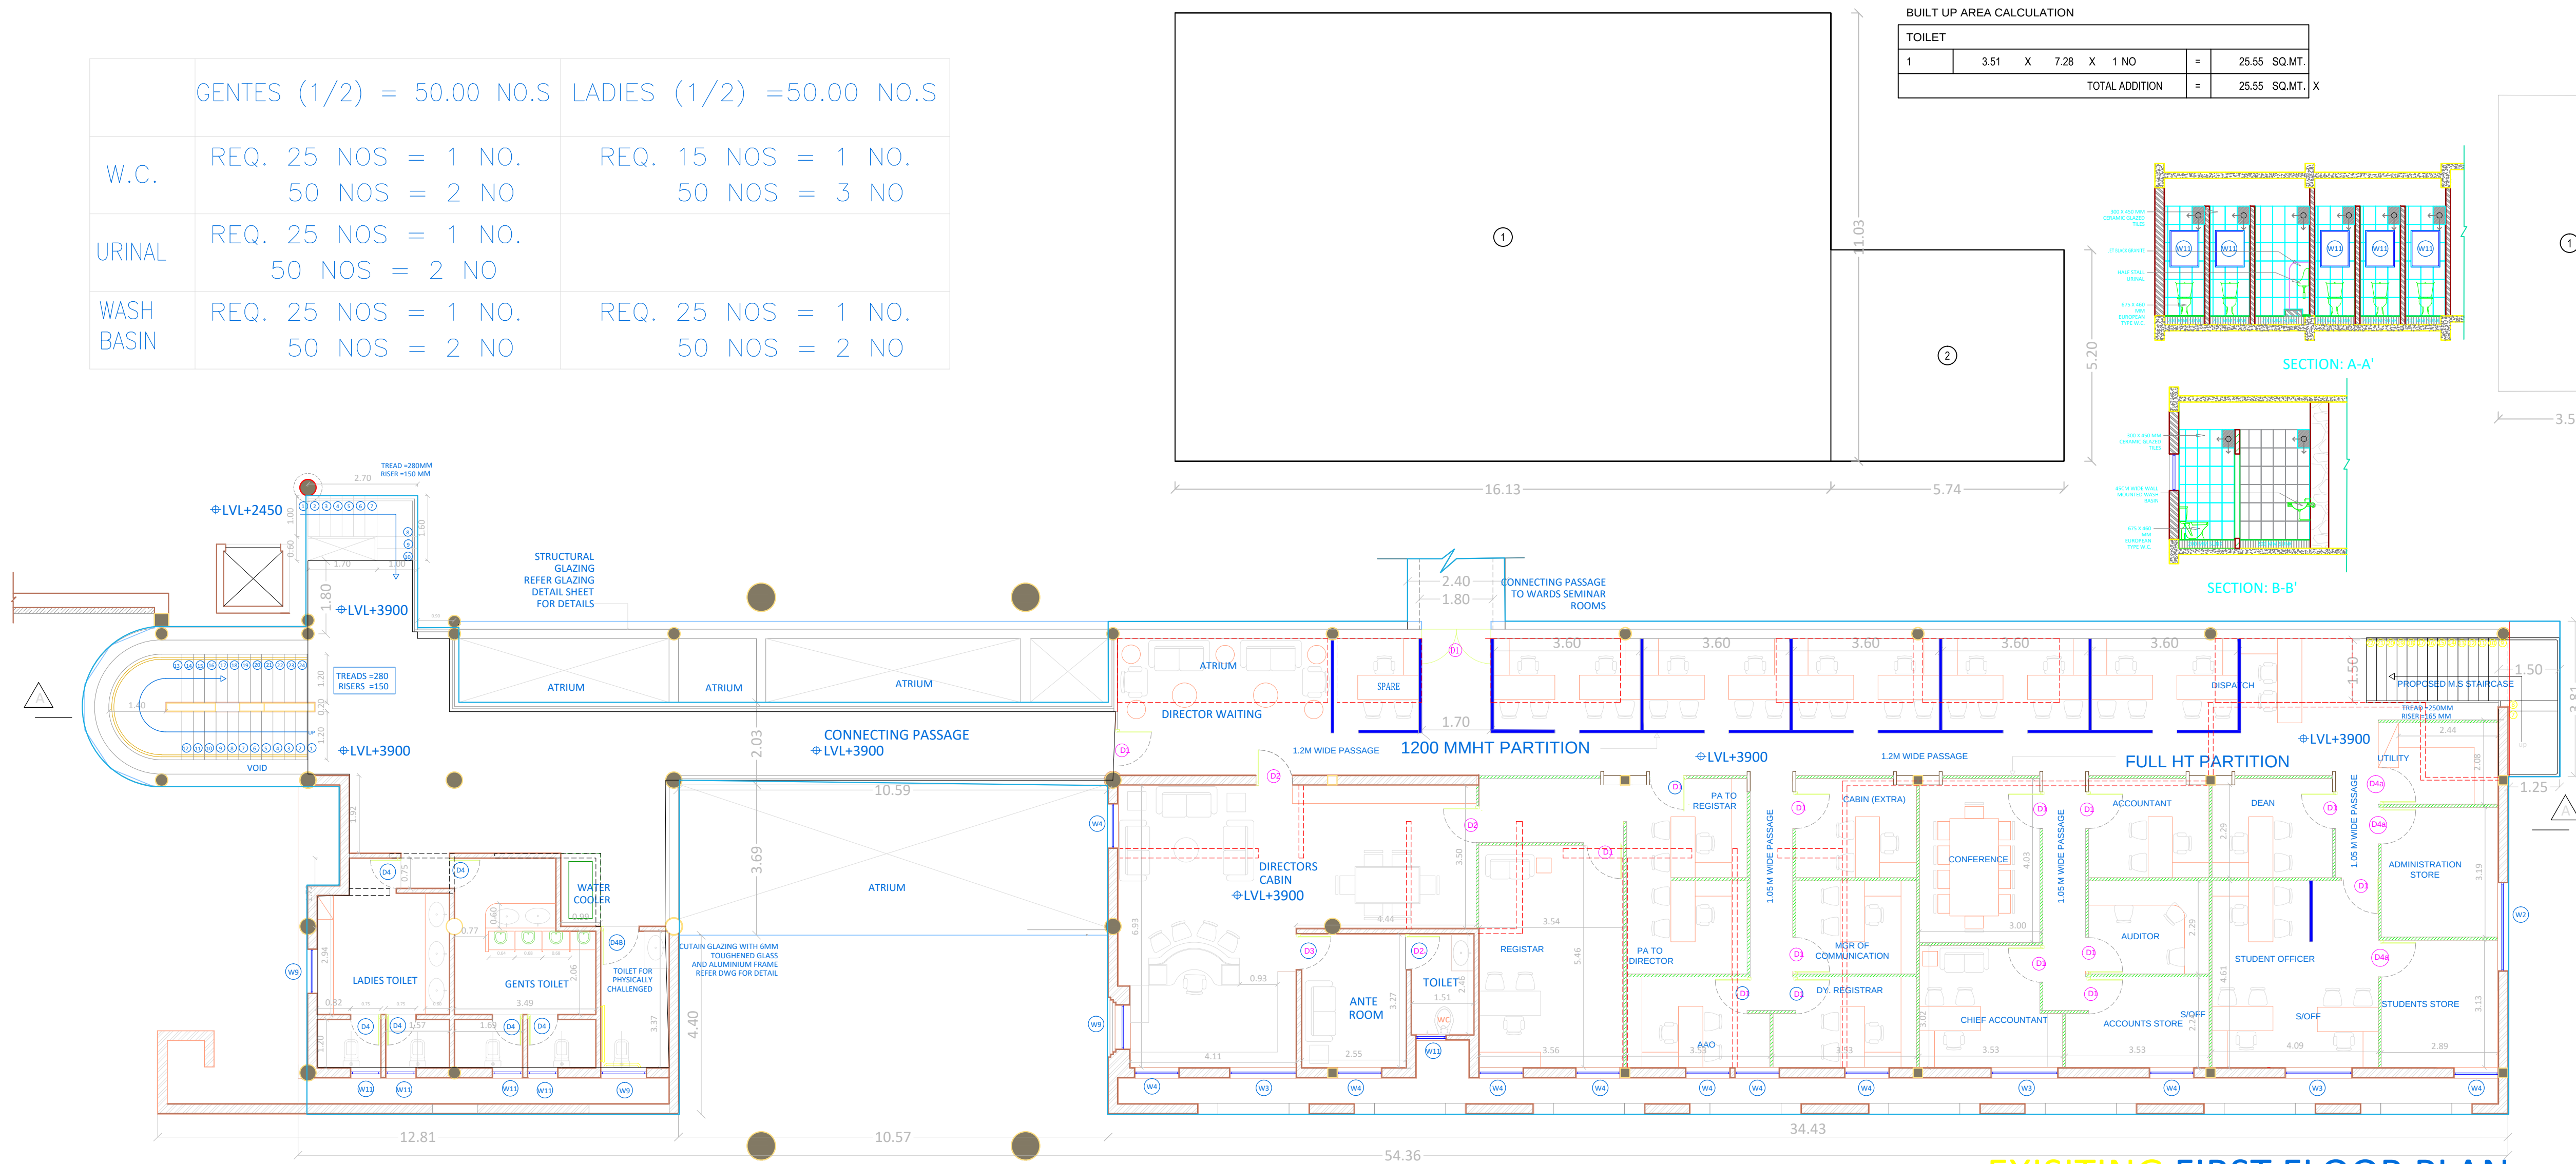

EXISTING FIRST FLOOR PLAN INTERIOR LAYOUT

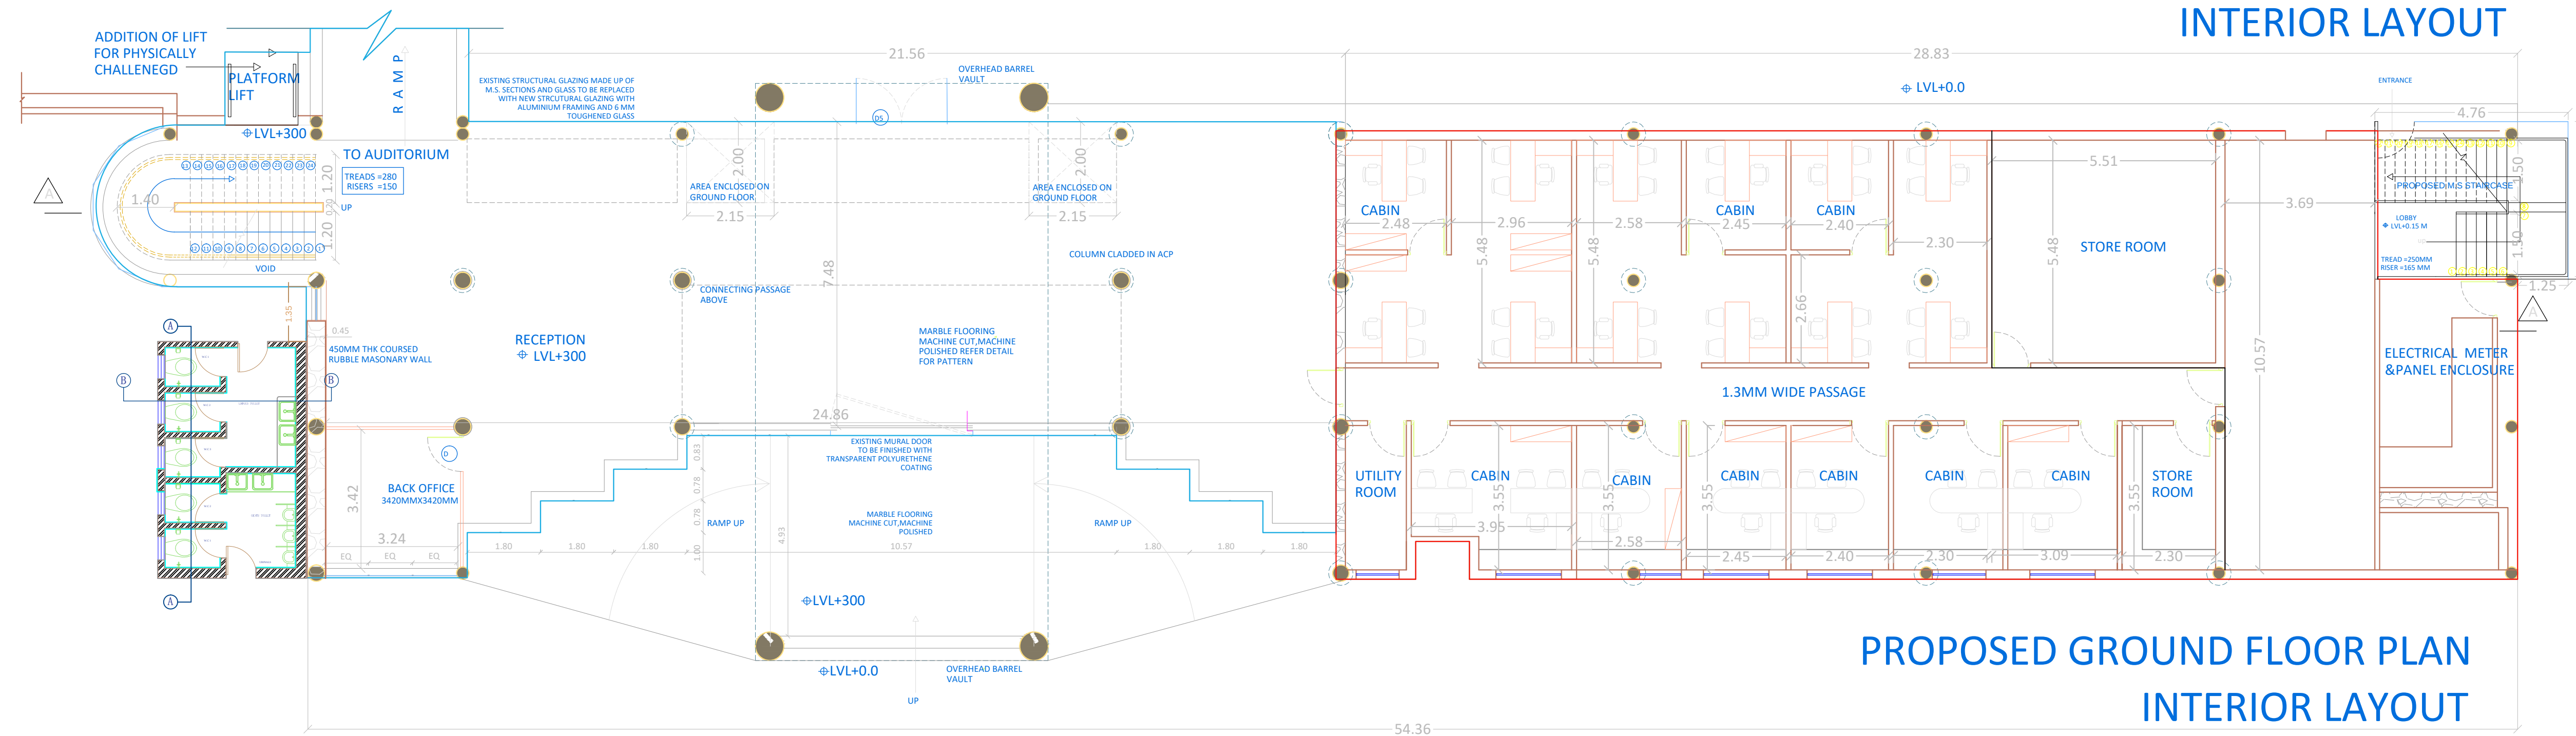

PROPOSED GROUND FLOOR PLAN INTERIOR LAYOUT

APPROVAL SUBJECT TO CONDITIONS MENTIONED IN FILE NO. CHE/734/BP(SPL CELL)/APs/337/342/1/New P/S Ward. Dated		
S.E.(B.P)SPL CELL P/S	A.E.(B.P)SPL CELL P/S	EX.Eng.(B.P)SPL CELL

STAMP AND DATE OF APPROVAL OF PLAN

DESCRIPTION OF PROPOSAL AND PROPERTY

Proposed addition/alteration to the existing building "A" i.e. Main Institute building at IGIDR (Indira Gandhi Institute of Development & Research) of the RBI on land bearing CTS No. 25(pt) of village Aarey , Goregaon (East), Mumbai

NAME OF OWNER

RESERVE BANK OF INDIA

DESIGN IDEAS

ARCHITECTURE, INTERIOR, PROJECT MANAGEMENT
GIRUA BHUVAN, ROOM No.-1, PLOT NO.163/B,
DR.AMBEDKAR ROAD ,OPP. PARSI GYMKHANA,
DADAR (EAST) ,MUMBAI - 400 014
TELEFAX-022-2412 1713 /2411 8778

NORTH

DATE


SHEET NO.

SCALE

1:100

DWG NO.

IGIDR/MD/8/2010

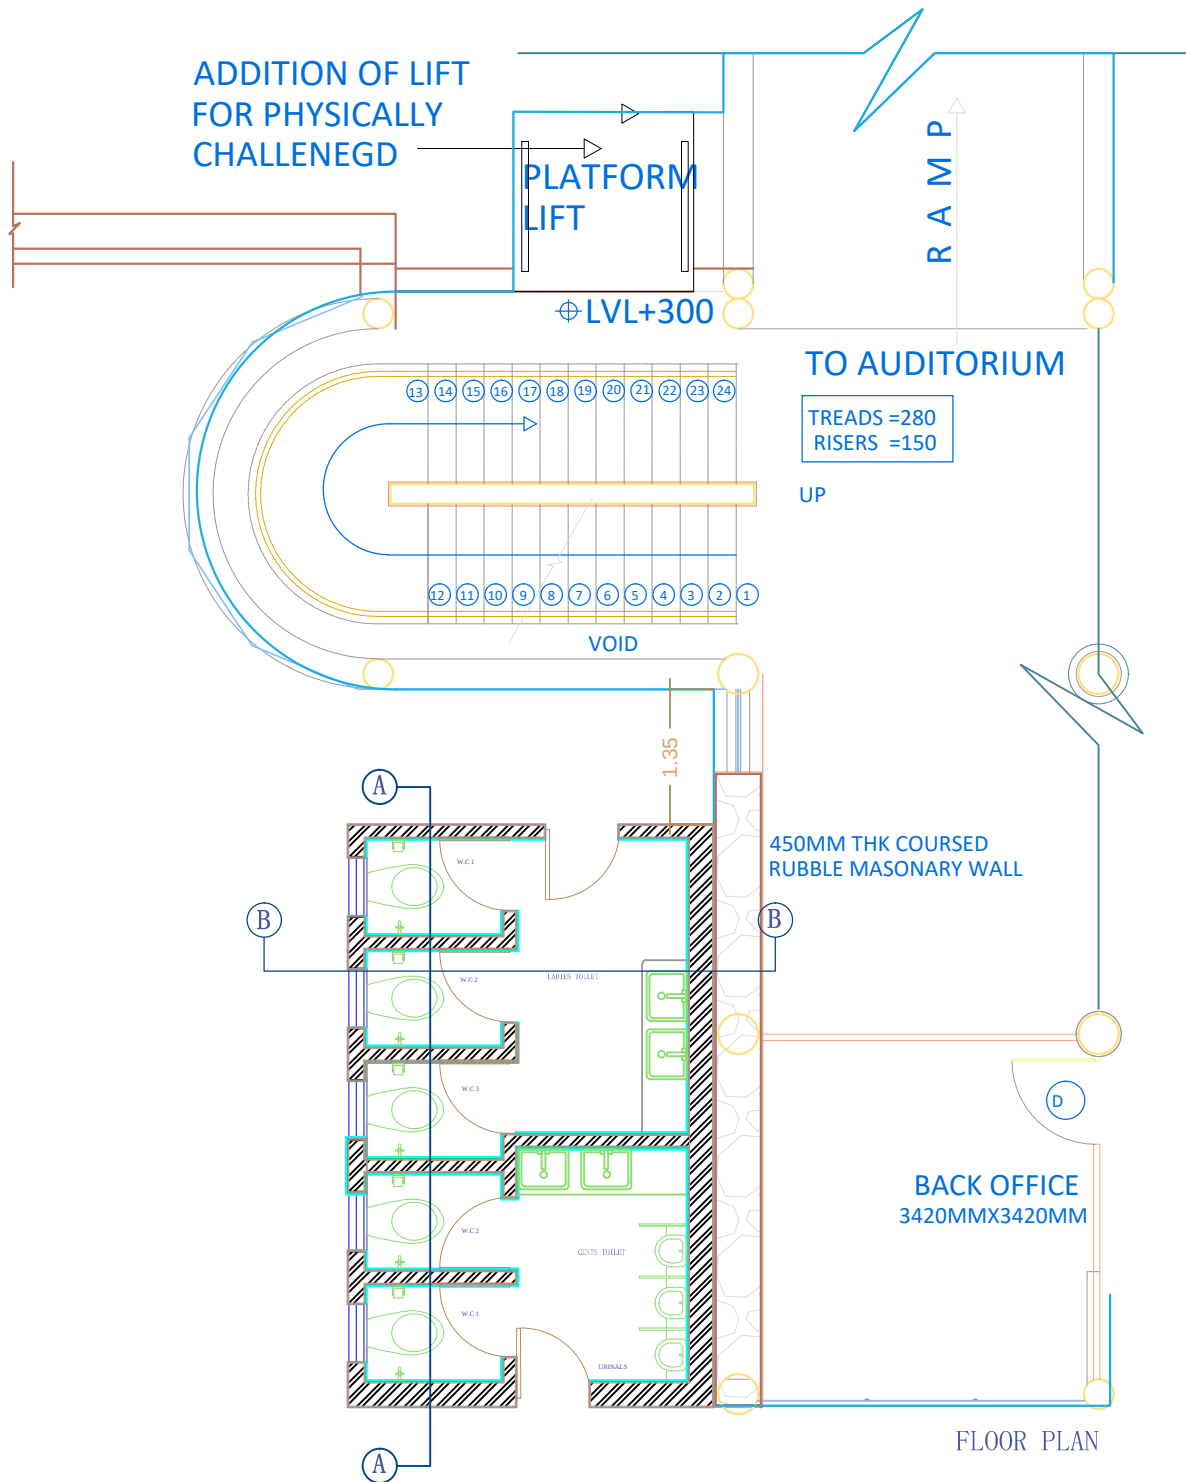

NOTE:-

DATE	2.7.2026
DATE	1:75
DRAWN	AC
CHECK	PP
APPROVED	PP
SHEET SIZE	A4- 297 mm x 210 mm

CLIENT		IGDR	
PROJECT		TOILET DETAIL DRAWINGS	
SHEET TITLE		TOILET DETAIL	
PROJECT NO.		DWG. NO.	
REV. NO.		REV. NO.	

The figure displays five sequential architectural floor plans of a building, illustrating the progression of Mechanical, Electrical, and Plumbing (MEP) layout design. The plans are labeled as follows:

- FIXTURES LAYOUT:** Shows the initial placement of fixtures such as toilets (WC1, WC2, WC3), sinks, and showers. Dimensions and grid lines (A, B) are indicated.
- FLOORING LAYOUT:** Shows the placement of flooring materials, including tiles and carpet, around the fixtures.
- PLUMBING LAYOUT:** Shows the placement of plumbing fixtures and piping, including water supply and waste lines.
- Ceiling Layout:** Shows the placement of ceiling fixtures and piping, including lighting and ventilation.
- SWITCH BOARD AND LOOPING LAYOUT:** Shows the placement of electrical switchboards and the looping of electrical cables.

A legend is provided for the symbols used in the plans:

SYMBOL	DESCRIPTION
[Symbol]	TOILET
[Symbol]	WATER SUPPLY
[Symbol]	WASTE
[Symbol]	CEILING LIGHT
[Symbol]	SWITCH BOARD
[Symbol]	WATER SUPPLY
[Symbol]	WASTE
[Symbol]	CEILING LIGHT
[Symbol]	SWITCH BOARD

The architectural drawings include two cross-sections and one floor plan:

- Cross-Section AA:** A longitudinal section through five toilet stalls. Components labeled from top to bottom are: FALSE CEILING LVL, 600x300mm WALL TILE, LOUVERED WINDOW, FLUSH VALVE FOR WC, URINAL, WALL HING. WC, and 200MM SUNK SLAB.
- Cross-Section BB:** A transverse section through the middle of the row of stalls. Components labeled from top to bottom are: FALSE CEILING LVL, 600x300mm WALL TILE, MIRROR, WASH BASIN, WALL HING. WC, and 200MM SUNK SLAB.
- Floor Plan:** Shows the layout of the dormitory toilet. It features a central corridor flanked by rows of stalls. Dimensions are provided for stall widths (e.g., 900, 1200) and heights (e.g., 2100). The title "DORMITORY TOILET" is at the bottom right.

[illegible]